



STAMP

NORTH

DATE	DEC 27/2019	PROJECT NO.	10-320
SCALE	N/A	DRAWN BY	MC
DWG. TITLE	SITE PLAN & LEGEND		
DWG. NO.	01	CHECKED BY	MC

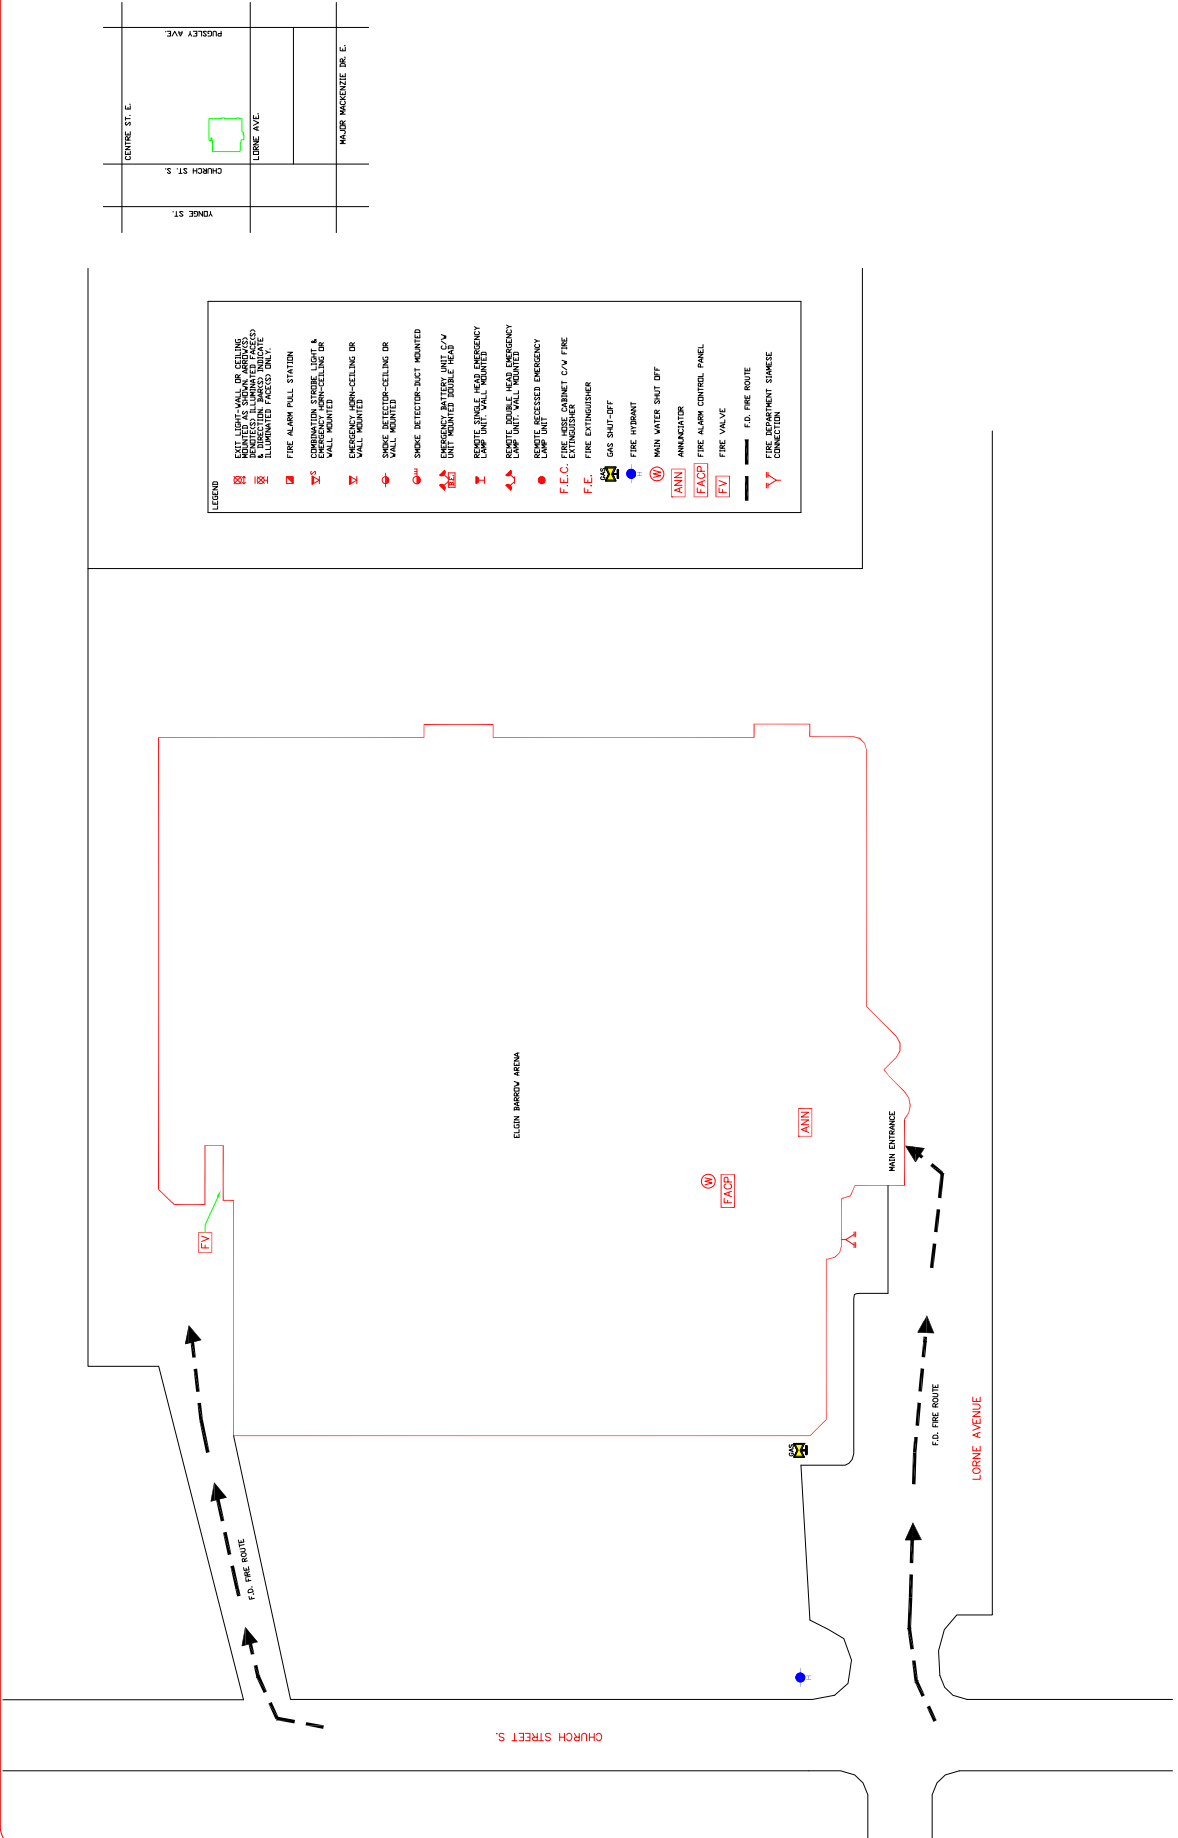

- LEGEND**
- FIRE ALARM PULL STATION
 - FIRE ALARM CONTROL PANEL
 - FIRE VALVE
 - FIRE EXTINGUISHER
 - FIRE HYDRANT
 - FIRE HOSE CABINET
 - FIRE DEPARTMENT SHACKLE CONNECTION
 - MAIN WATER SHUT OFF
 - ANNUNCIATOR
 - FIRE ALARM CONTROL PANEL
 - FIRE VALVE
 - F.D. FIRE ROUTE
 - FIRE DEPARTMENT SHACKLE CONNECTION
 - FIRE ALARM PULL STATION
 - FIRE ALARM CONTROL PANEL
 - FIRE VALVE
 - FIRE EXTINGUISHER
 - FIRE HYDRANT
 - FIRE HOSE CABINET
 - FIRE DEPARTMENT SHACKLE CONNECTION
 - MAIN WATER SHUT OFF
 - ANNUNCIATOR
 - FIRE ALARM CONTROL PANEL
 - FIRE VALVE
 - F.D. FIRE ROUTE
 - FIRE DEPARTMENT SHACKLE CONNECTION

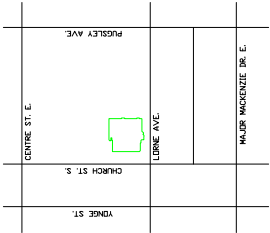

CHURCH STREET S.

ELGIN BARCOV ARENA

LORNE AVENUE


MAIN ENTRANCE

F.D. FIRE ROUTE

F.D. FIRE ROUTE


NO.	REVISIONS	DATE

MIRENDA
 CONSULTING ARCHITECTS P.A.
 15171 Longmeadow Lane, Suite 202
 Dallas, Texas 75244
 (972) 467-7200
 (972) 467-7201
 (972) 467-7202
 (972) 467-7300

STAMP
 NORTH



PROJECT
 FIRE SAFETY PLAN
 CLUB & BARROW ARENA
 4300 BARROW AVENUE
 ADDISON, TX 75001
 DATE TITLE
 LEVEL 1

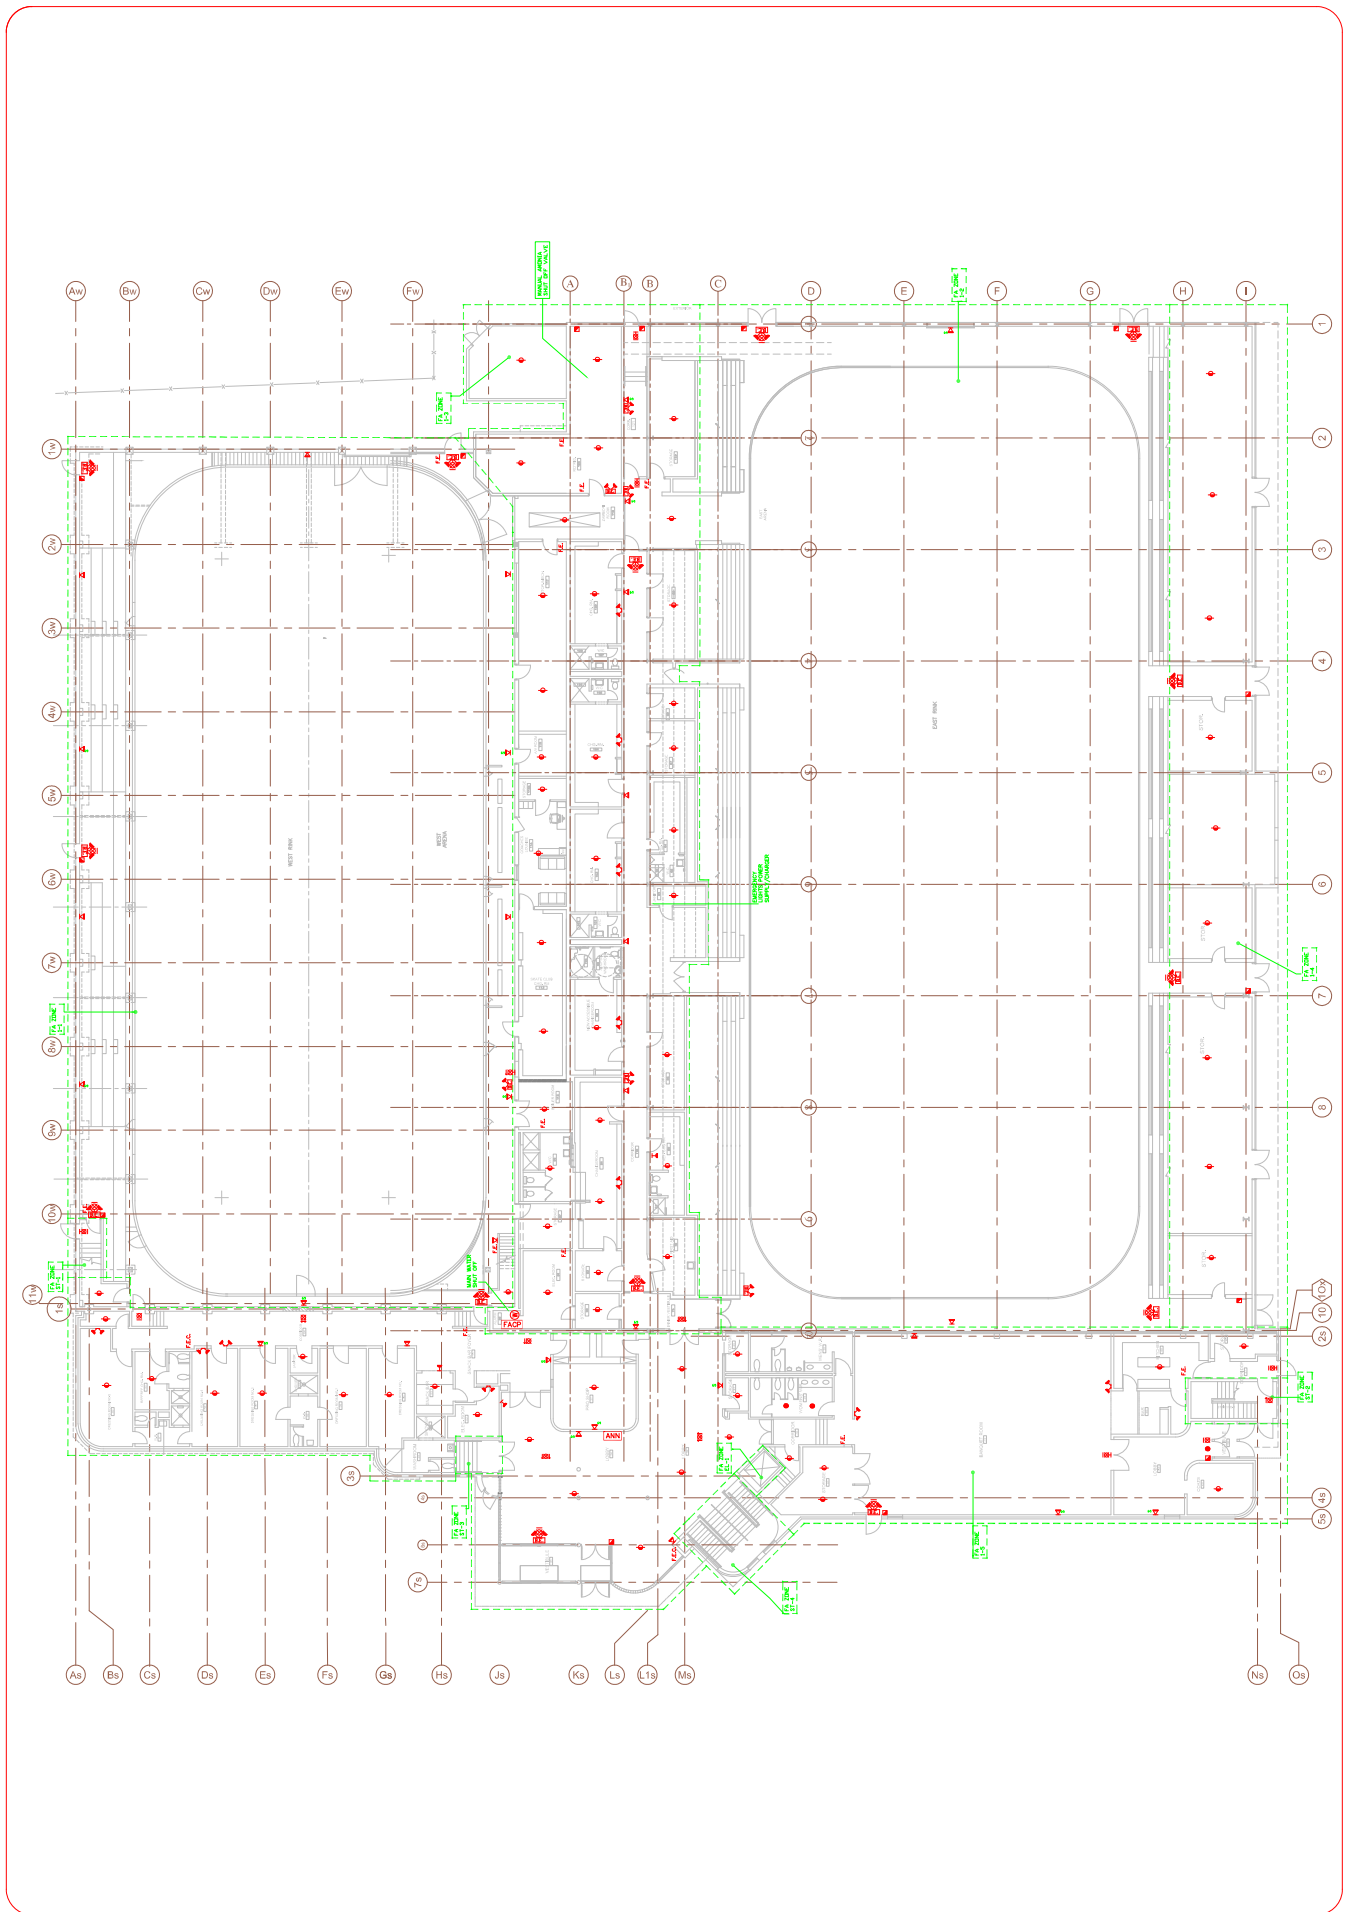PROJECT NO.
 10-320
 SCALE
 1/8" = 1'-0"
 DATE
 02/20/10
 DRAWN BY
 JAC
 CHECKED BY
 JAC



NO.	REVISIONS	DATE	BY

MIRENDA
 CONSULTANTS
 1571 Yonge Street, Suite 202
 Toronto, Ontario M5E 1W1
 Tel: 416-779-4281
 Fax: 416-779-5377

STAMP
 NORTH


PROJECT
 FIRE SAFETY PLAN
 ELGIN BARROW ARENA
 43 GERRARD AVE. EAST, TORONTO
 DWG TITLE
 LEVEL 2

PROJECT NO.
 10-320
 DATE
 DEC 27/2018
 SCALE
 NTS
 DWG BY
 MC
 DWG NO.
 03

