
 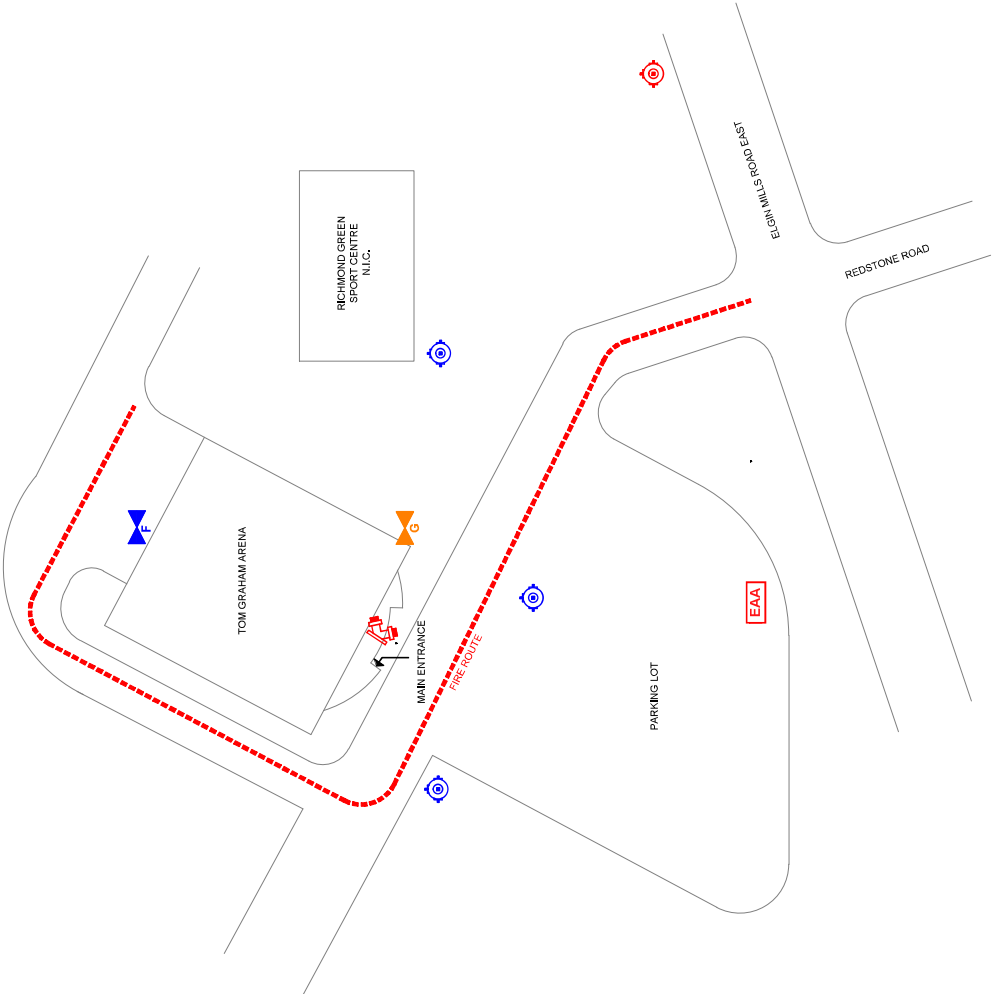


SITE PLAN



LEGEND

SYMBOL	SYMBOL DESCRIPTION
	FIRE ALARM AND CONTROL PANEL
	REMOTE ANNUNCIATOR
	PASSIVE GRAPHIC DISPLAY
	ROOF ACCESS
	COMBINATION EMERGENCY LIGHT AND BATTERY PACK - 2 HEADS
	COMBINATION EMERGENCY LIGHT AND BATTERY PACK - 4 HEADS
	REMOTE DOUBLE HEAD EMERGENCY LIGHT
	REMOTE SINGLE HEAD EMERGENCY LIGHT
	MAIN SPRINKLER SHUT OFF VALVE
	WET CHEMICAL AGENT TANK
	KITCHEN HOOD SUPPRESSION SYSTEM
	MANUAL ACTIVATION STATION (KHSS)
	STROBE LIGHT FOR AMMONIA GAS
	KING VALVE (AMMONIA GAS)
	FIRE VALVE (AMMONIA GAS)
	FIRE DEPARTMENT CONNECTION
	MUNICIPAL FIRE HYDRANT
	PRIVATE FIRE HYDRANT
	PORTABLE FIRE EXTINGUISHER 10LB ABC
	PORTABLE FIRE EXTINGUISHER 5LB ABC
	A-TYPE PORTABLE FIRE EXTINGUISHER
	MAIN GAS SHUT-OFF
	ELECTRICAL SHUT-OFF
	FIRE SAFETY PLAN BOX
	DESIGNATED EXIT
	FIRE ROUTE
	EVACUATION ASSEMBLY AREA

DRAWING LIST

SYMBOL	DESCRIPTION
FSP-01	COVER PAGE (INCLUDES SITE PLAN, LEGEND AND DRAWING LIST)
FSP-02	GROUND FLOOR
FSP-03	SECOND FLOOR

ISSUED FOR REVIEW	01/24/2018	DATE	NO.	REVISION DESCRIPTION	
<div style="display: flex; justify-content: space-between;"> <div style="width: 45%;"> <p>APCC CANADA 24 MONTCLAIR ROAD, RICHMOND HILL, ON L4B 1L4 TEL: 905.882.9043 (Email: j.patel@apcccanada.com)</p> </div> <div style="width: 45%;"> <p>DAVID HINE ENGINEERING INC. 21 MCLELLAN COURT, TORONTO, ONTARIO, M9W 6M6 www.dhinc.ca</p> </div> </div>					
<p>TOM GRAHAM ARENA 1300 ELGIN MILLS ROAD EAST RICHMOND HILL, ONTARIO</p>					
PROJECT NUMBER: -		DRAWING TITLE: COVER PAGE		DRAWING NUMBER: FSP-1	
DATE: N.T.S.	SCALE: N.T.S.	DATE: JAN 12, 2018	DATE: JAN 12, 2018	DATE: JAN 12, 2018	DATE: JAN 12, 2018
DESIGNED BY: J.K.	CHECKED BY: C.V.	DATE: JAN 12, 2018	DATE: JAN 12, 2018	DATE: JAN 12, 2018	DATE: JAN 12, 2018

NO.	DATE	REVISION DESCRIPTION
0.0	04/11/18	ISSUED FOR REVIEW

CONSTANT
APC CANADA
 THE FOUNDATION CONSULTING
 24 MONTCLAIR ROAD,
 RICHMOND HILL,
 ON L4B 2T3
 TEL: 905.886.8000
 www.apc.ca
 DAVD HINE ENGINEERING INC.
 21 MCLELLAN COURT, TORONTO, ONTARIO, M9W 4M6
 TEL: 416.498.8000

PROJECT NAME	TOM GRAHAM ARENA
PROJECT NUMBER	-
SCALE	N.T.S.
DATE	JAN 12, 2018
DESIGNED BY	J.R.
CHECKED BY	J.R.
DATE	JAN 12, 2018
PROJECT LOCATION	1300 EGLIN MILLS ROAD EAST RICHMOND HILL, ONTARIO

